

- GENERAL NOTES
1.

EXISTING CONDITIONS SHOWN ON THIS PLAN ARE REFERENCED FROM A SITE PLAN PREPARED BY J3 ENGINEERING, ENTITLED SITE PLAN, DATED 11/06/2015.
2.

THIS PLAN IS SHOWN FOR REFERENCE OF THE OVERALL FACILITY AND LOCATION OF THE PROPOSED WORK AREA INCLUDED WITH THIS APPLICATION.
3.

THIS PLAN IS PREPARED FOR GRAPHICAL PURPOSES ONLY, AND IS NOT INTENDED TO BE USED FOR CONSTRUCTION.
4.

THE PROPOSED WORK INCLUDED WITH THIS APPLICATION IS FOR TWO(2) COMBINED HEAT AND POWER (CHP) UNITS TO BE PLACED BEHIND THE CONVENTION CENTER, ADJACENT TO THE LOADING DOCK AREA.

OVERALL SITE PLAN

SCALE  
1"=100'

1

NOT FOR  
CONSTRUCTION

OVERALL  
SITE PLAN

SHEET NUMBER

UNISON  
ENERGY

22 WEST PUTNAM AVENUE  
GREENWICH, CT 06830  
(917) 974-7686 | WWW.UNISONENERGY.COM

NEW CONSTRUCTION OF  
COMBINED HEAT AND  
POWER SYSTEM  
6700 N GAYLORD ROCKIES BLVD  
AURORA, CO 80019

CORE STATES  
CONSTRUCTION SERVICES, INC.

446 MARKET STREET  
SUITE 201  
DENVER, CO 80202  
303.662.2700

DOCUMENT PREPARED BY CORE STATES GROUP INCLUDING THIS DOCUMENT ARE TO BE USED ONLY FOR THE SPECIFIC PROJECT AND SPECIFIC USE FOR WHICH THEY WERE INTENDED. ANY EXTENSION OF USE OR BY ANY OTHER PARTY WITHOUT THE WRITTEN CONSENT OF CORE STATES CONSTRUCTION SERVICES, INC. SHALL BE UNLAWFUL AND AT THE USER'S OWN RISK. CORE STATES GROUP SHALL HOLD CORE STATES GROUP HARMLESS FROM ALL CLAIMS AND LOSSES.

SEAL

| REV | DATE     | DESCRIPTION     |
|-----|----------|-----------------|
| -   | 12-10-20 | LAND USE REVIEW |
|     |          |                 |
|     |          |                 |
PROJECT INFORMATION

JOB #

UNE-27889

DATE:

10.18.19

DRAWN BY:

PB

CHECKED BY:

AG

MODEL

(2) x 2000KW


SHEET TITLE

OVERALL SITE PLAN

SHEET NUMBER

2.0



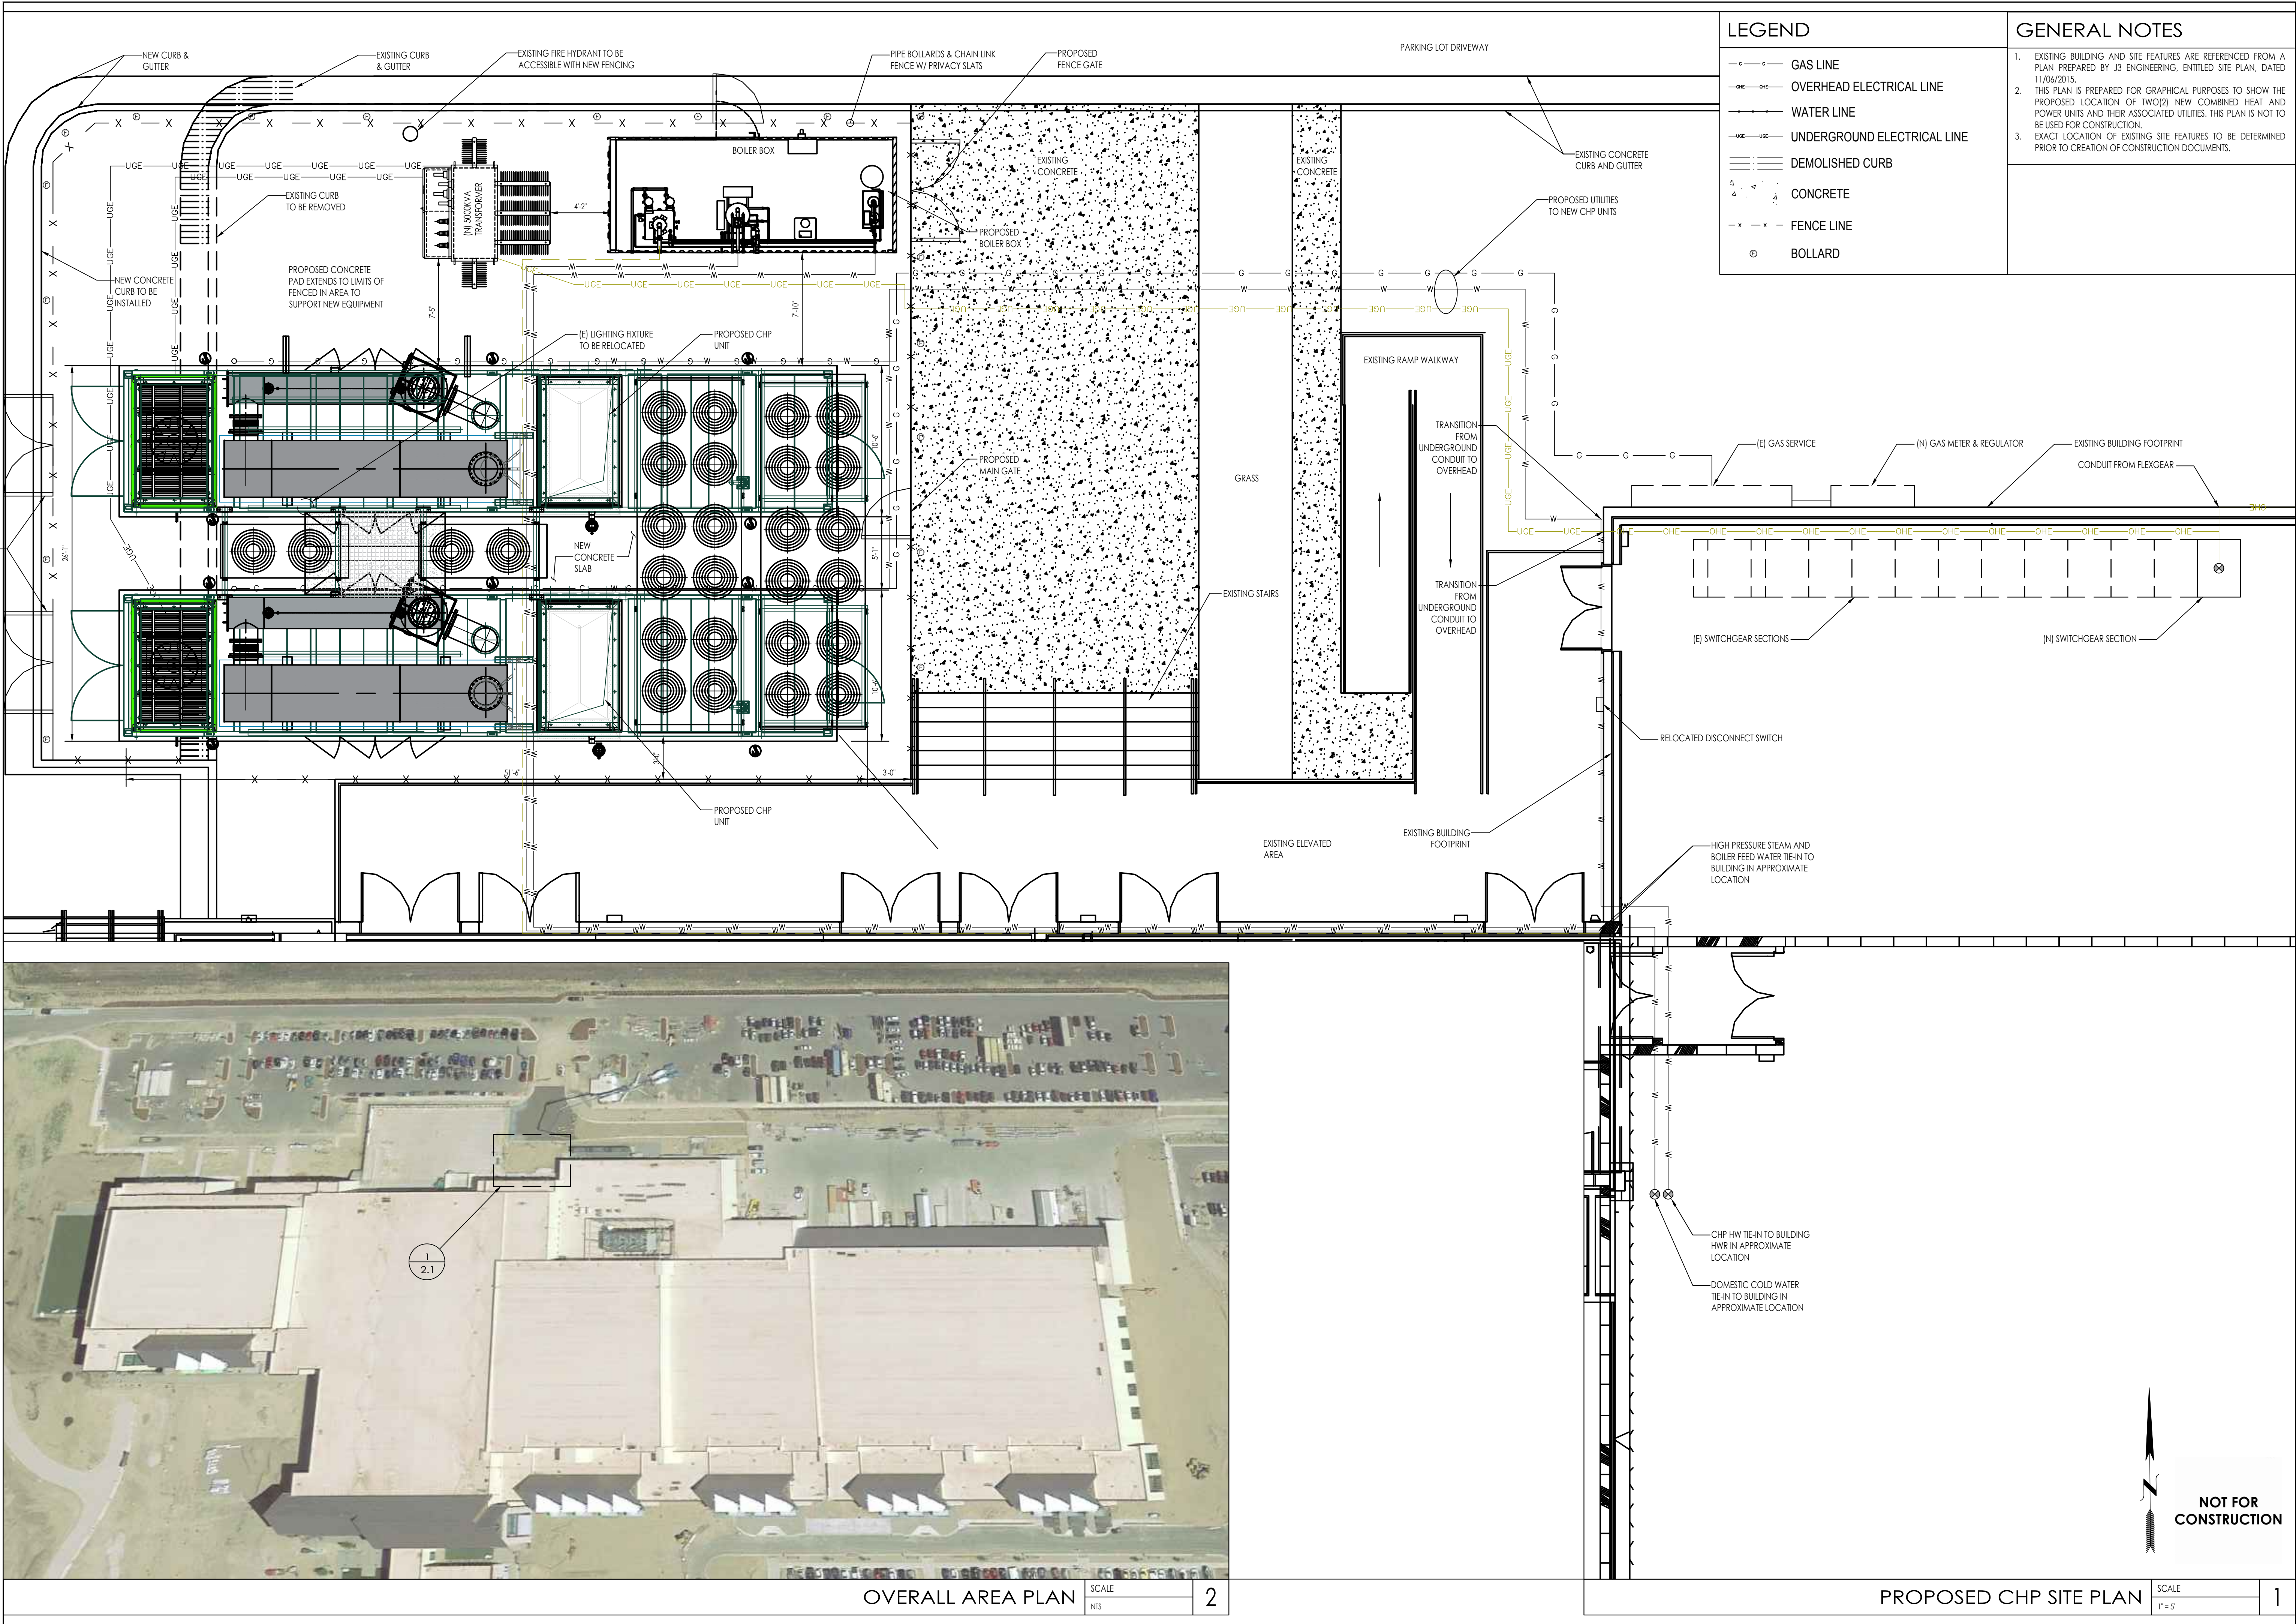

**LEGEND**

- GAS LINE
- OVERHEAD ELECTRICAL LINE
- WATER LINE
- UNDERGROUND ELECTRICAL LINE
- DEMOLISHED CURB
- CONCRETE
- FENCE LINE
- BOLLARD

**GENERAL NOTES**

- EXISTING BUILDING AND SITE FEATURES ARE REFERENCED FROM A PLAN PREPARED BY J3 ENGINEERING, ENTITLED SITE PLAN, DATED 11/06/2015.
- THIS PLAN IS PREPARED FOR GRAPHICAL PURPOSES TO SHOW THE PROPOSED LOCATION OF TWO(2) NEW COMBINED HEAT AND POWER UNITS AND THEIR ASSOCIATED UTILITIES. THIS PLAN IS NOT TO BE USED FOR CONSTRUCTION.
- EXACT LOCATION OF EXISTING SITE FEATURES TO BE DETERMINED PRIOR TO CREATION OF CONSTRUCTION DOCUMENTS.

**UNISON ENERGY**

22 WEST PUTNAM AVENUE  
GREENWICH, CT 06830  
(917) 974-7686 | WWW.UNISONENERGY.COM

NEW CONSTRUCTION OF  
COMBINED HEAT AND  
POWER SYSTEM

6700 N GAYLORD ROCKIES BLVD  
AURORA, CO 80019

**CORE STATES**  
CONSTRUCTION SERVICES, INC.

446 MARKET STREET, SUITE 201  
DENVER, CO 80202  
303.662.9700

DOCUMENT PREPARED BY CORE STATES GROUP, INCLUDING THIS DOCUMENT, ARE TO BE USED ONLY FOR THE SPECIFIC PROJECT AND SITE IDENTIFIED HEREIN. ANY EXTENSION OF USE OR REUSE OF THIS DOCUMENT OR BY ANY OTHER PARTY WITHOUT THE WRITTEN CONSENT OF CORE STATES GROUP SHALL BE UNLAWFUL AND AT THE USER'S OWN RISK. CORE STATES GROUP WILL HOLD CORE STATES GROUP HARMLESS FROM ALL CLAIMS AND LOSSES.

SEAL

| REV | DATE     | DESCRIPTION     |
|-----|----------|-----------------|
| 1   | 12-10-20 | LAND USE REVIEW |

PROJECT INFORMATION

JOB # UNF-27889

DATE: 10.18.19

DRAWN BY: VL

CHECKED BY: ARM

MODEL

(2) x 2000KW

SHEET TITLE

AMENDED SITE PLAN

SHEET NUMBER

2.1