
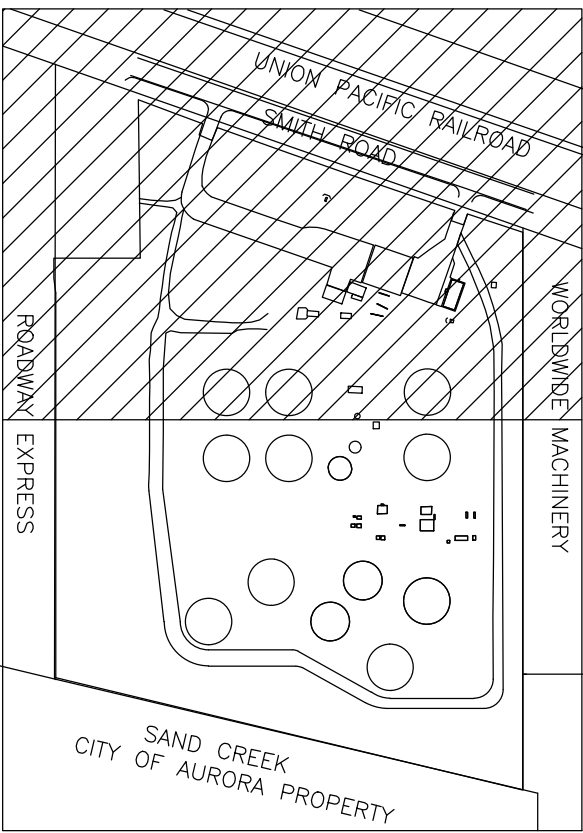


NOTE:
1. MAGELLAN PIPELINE CO. IS RESPONSIBLE FOR CONSTRUCTION AND MAINTENANCE OF THE FIRE ACCESS LANE. THE MAINTENANCE INCLUDES BUT IS NOT LIMITED TO SNOW REMOVAL, GRADING AND NECESSARY IMPROVEMENTS COMPLYING WITH THE STANDARDS OF THE INTERNATIONAL FIRE CODE

A license agreement is required for the proposed pipeline crossing Aurora Water's utility easement. The license agreement documents show the pipeline being installed 15' above the utility easement. The site plan and license agreement need to be in agreement for the utility crossing. Include a detail of the proposed water main crossing showing the pipe layout.


License Agreement required for pipeline and/or equipment crossing Fire lane and other easement

Contact Grace Gray for License Agreement

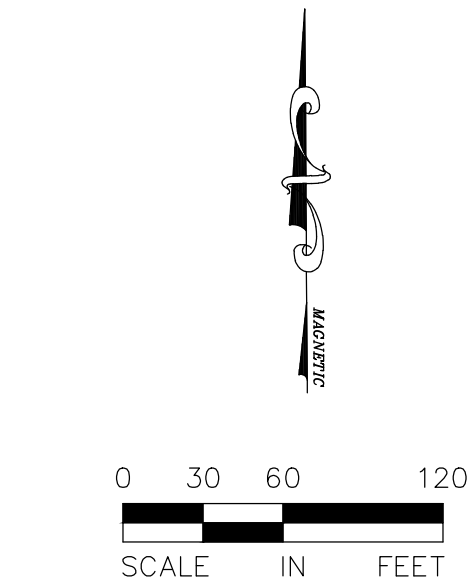

LEGEND

- EXISTING HYDRANT
- POWER POLE
- LIGHT/FLOOD
- EXISTING FENCE
- EXISTING WATERMAIN
- EXISTING ASPHALT DRIVE
- EXISTING BUILDING/SHED
- EXISTING CONCRETE
- REMOVE EXISTING WATERMAIN
- EXIST. UTILITY/FIRE LANE EASEMENT
- VACATED EASEMENT
- NEW EASEMENT
- NEW PIPING
- NEW CONTAINMENT DRAIN
- NEW WATERMAIN
- NEW SANITARY

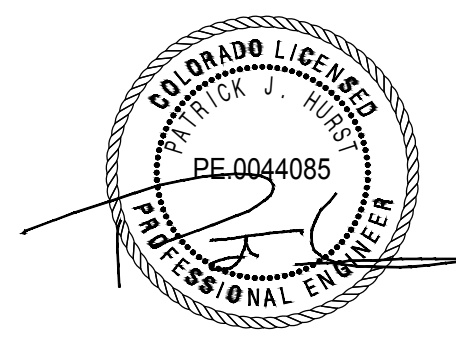

6/21/2019

ISSUED FOR
JUNE 21, 2019
SITE PLAN AMENDMENT

esdc
ENGINEERING
Mechanical • Electrical • Structural • Fire Protection
624 S. Boston, Suite 600
Phone: (918) 949-3670
Tulsa, OK 74119
Fax: (918) 949-3672

5	2019 SITE PLAN AMENDMENT FIRST SUBMITTAL A.F.E. 283-2019-7901	PGH	4/18/19	DAW	C. VANENGEN
4	2015 SITE PLAN AMENDMENT FIRST SUBMITTAL A.F.E. 280-2015-4500	DAW	8/19/15	DAW	C. VANENGEN
3	TRANSMIX & BUTANE INJECTION	JM	1/13/11	P. HURST	K. HOWELL
2	2007 MINOR SITE PLAN AMENDMENT				
1	2006 SITE PLAN AMENDMENT SECOND SUBMITTAL				
0	2006 SITE PLAN AMENDMENT FIRST SUBMITTAL				
REVISION NUMBER	DRAWN BY	DATE REVISED	CHECKED BY	PROJECT ENGINEER	APPROVED BY

MAGELLAN
MIDSTREAM PARTNERS, L.P.

MAGELLAN CHASE TERMINAL SITE PLAN AMENDMENT SITE PLAN — NORTH END LOT 1, BLOCK 1, KOCH INDUSTRIES, INC. AURORA, CO.					
DRAWN BY	DAW	SCALE	1"=60'-0"	A.F.E.	283-2019-7901
DATE DRAWN	8/17/15	DRAWING NO.			
CHECKED BY	PH	259-D-PRJ002			
PROJECT ENGINEER	CV				
APPROVED BY					
		5			